
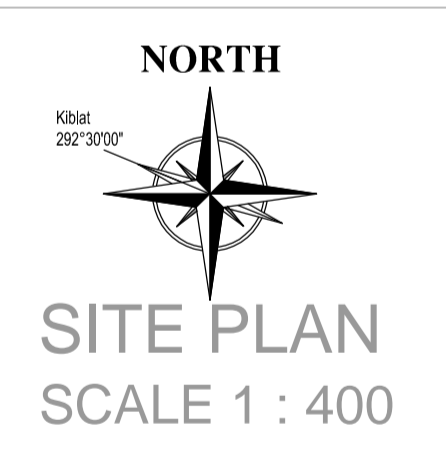


LEGEND FOR FIRE PROTECTION SYSTEM

ITEM	LEGEND	DESCRIPTION
1	○	UPRIGHT SPRINKLER (HEAD/POINT)
2	●	PENDENT SPRINKLER (HEAD/POINT)
3	⊙	DOUBLE LAYER SPRINKLER (HEAD/POINT)
4	⊗	CUT OFF SPRINKLER (HEAD/POINT)
5	⊕	FLOW SWITCH
6	⊕	BUTTERFLY VALVE
7	⊕	SPRINKLER ALARM VALVE
8	⊕	GATE VALVE
9	⊕	MANUAL CALL POINT
10	⊕	FIRE ALARM BELL
11	⊕	2.27KG CARBON DIOXIDE PORTABLE FIRE EXTINGUISHER
12	⊕	9KG ABC DRY POWDER PORTABLE FIRE EXTINGUISHER
13	⊕	30MM/1 INCH GANGLER HOSE 2 x 30m LONG x 65mm CANVAS HOSE
14	⊕	& 1 NO. OF JET & SPRAY NOZZLE
15	⊕	2-WAY DOUBLE OUTLET PILLAR HYDRANT C/W LANDING VALVE
16	⊕	PUMP CONTROL PANEL (SPRINKLER)
17	⊕	FIRE ALARM CONTROL PANEL (ADDRESSABLE/ANALOGUE)
18	⊕	CONDUIT TYPE HOSE REEL TRIM C/W 1 x 30m LONG x 25mm NON-KINK HOSE AND 1 NO. OF JET & SPRAY NOZZLE
19	⊕	KELUAR SIGN
20	⊕	EMERGENCY LIGHT
21	⊕	MAIN FIRE PUMPSET (ELECTRICITY)
22	⊕	MAIN FIRE PUMPSET (DIESEL/GENERATOR)
23	⊕	JOCKEY PUMPSET (ELECTRICITY)
24	⊕	WATER METER
25	⊕	4-WAY BREACHING INLET C/W NON RETURN CHECK VALVE

NO	DRAWING TITLE	DRAWING NO
1	- SITE PLAN, KEY PLAN & LOCATION PLAN - HYDRANT SYSTEM	3445/NF/AAC/2018-FF00
SPRINKLER SYSTEM		
2	GROUND FLOOR PLAN	3445/NF/AAC/2018-FF01
3	FIRST FLOOR PLAN	3445/NF/AAC/2018-FF02
4	SECOND FLOOR PLAN	3445/NF/AAC/2018-FF03
5	BLOW-UP OFFICE AREA	3445/NF/AAC/2018-FF04
HOSE REEL & FIRE ALARM SYSTEM		
6	GROUND FLOOR PLAN	3445/NF/AAC/2018-FF05
7	FIRST FLOOR PLAN	3445/NF/AAC/2018-FF06
8	SECOND FLOOR PLAN	3445/NF/AAC/2018-FF07
SCHEMATIC DIAGRAM & DETAILS DRAWING		
9	SCHEMATIC DIAGRAM FOR SPRINKLER SYSTEM	3445/NF/AAC/2018-FF08
10	SCHEMATIC DIAGRAM FOR HOSE REEL SYSTEM	3445/NF/AAC/2018-FF09
11	CO2 SYSTEM	3445/NF/AAC/2018-FF10
12	CO2 SYSTEM & FM200 SYSTEM	3445/NF/AAC/2018-FF11
13	SINGLE LINE DIAGRAM & DETAILS DRAWING	3445/NF/AAC/2018-FF12
14	DETAILS DRAWING NO.1	3445/NF/AAC/2018-DTL-1
15	DETAILS DRAWING NO.2	3445/NF/AAC/2018-DTL-2
16	DETAILS DRAWING NO.3	3445/NF/AAC/2018-DTL-3

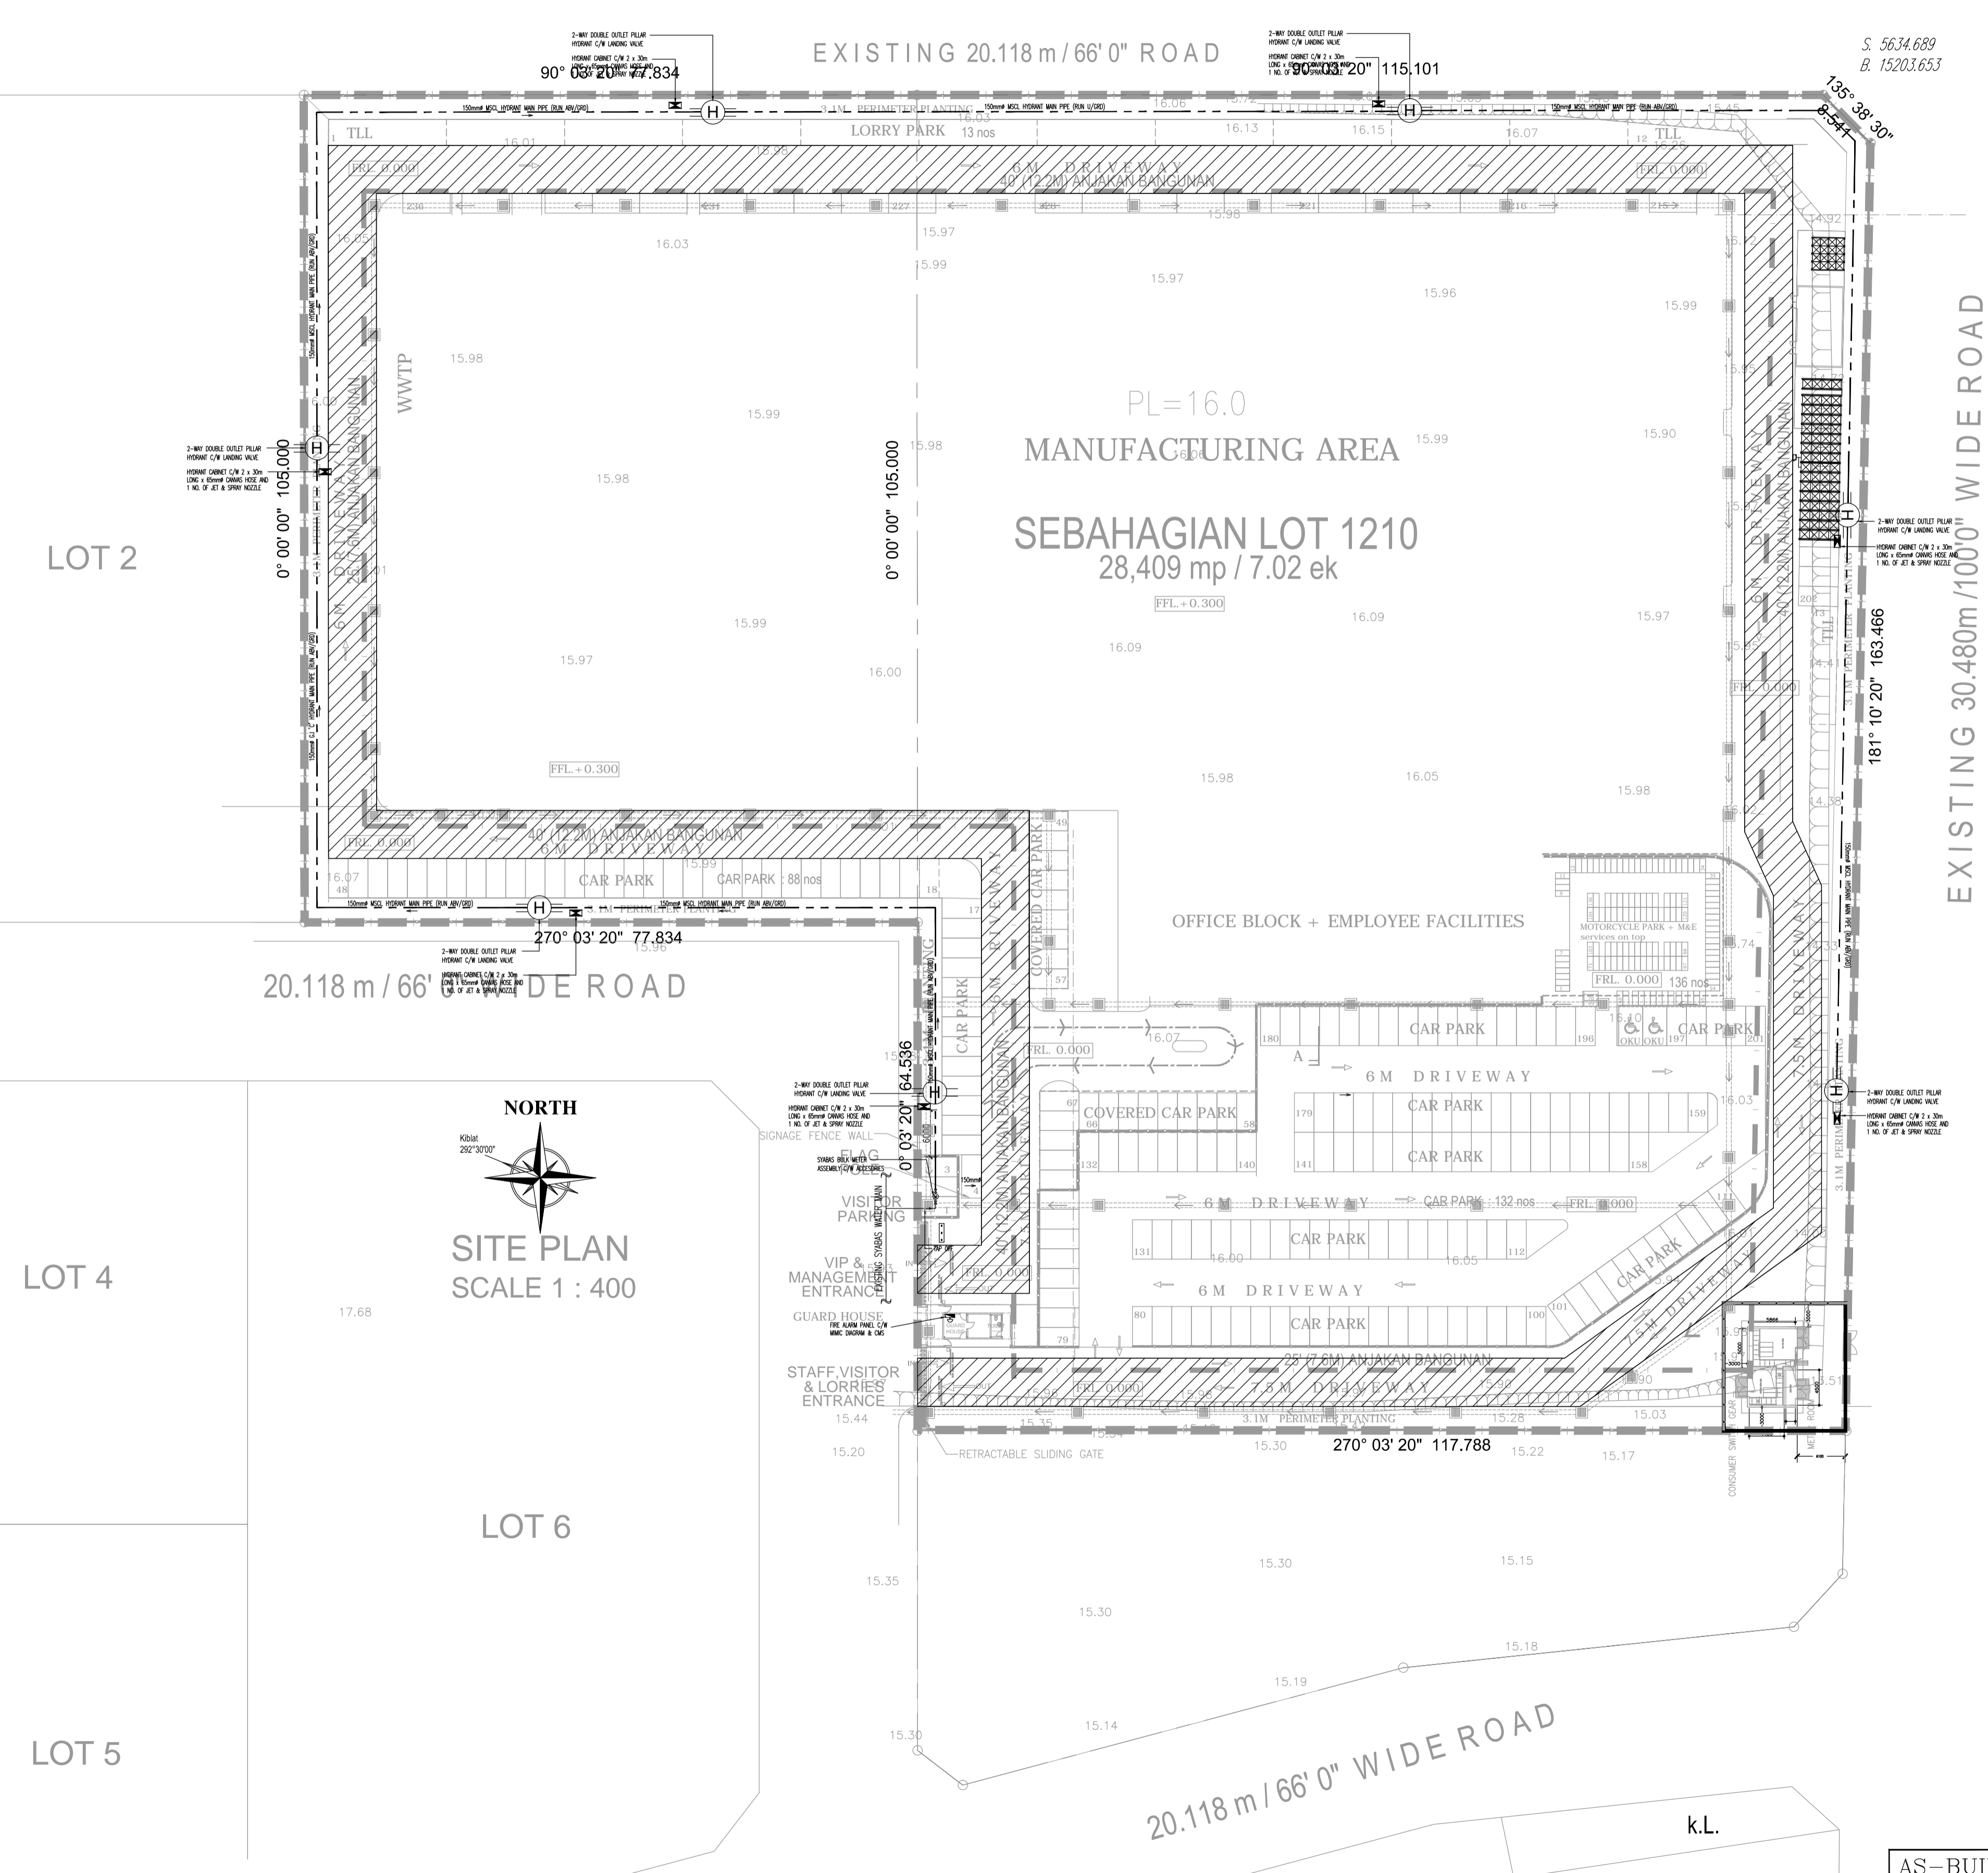

TAJUK PROJEK :
**PERMOHONAN KEBENARAN MERANCANG
 PENDIRIAN BANGUNAN BAGI CADANGAN
 PEMBANGUNAN KILANG PENGELUARAN
 KOMPONEN KAPAL TERBANG DI ATAS
 SEBAHAGIAN LOT 1210, SEKSYEN U3, 40150
 MUKIM DAMANSARA, DAERAH PETALING,
 SELANGOR DARUL EHSAN.**

UNTUK TETUAN :
**RHB TRUSTEES BERHAD
 (As Trustee for Axis Real Estate Investment Trust)**

PEMILIK TANAH :
**MALAYSIA AIRPORTS HOLDING BERHAD
 (MAHB) (487992-W)
 MALAYSIA AIRPORTS CORPORATION OFFICE,
 PERSIARAN KORPORAT KLIA,
 64000 KLIA, SEPANG,
 SELANGOR DARUL EHSAN
 Tel: +603 8777 7000 Fax: +603 8777 7589**

PEMILIK BANGUNAN :
**RHB TRUSTEES BERHAD (573019-U)
 (As Trustee for Axis Real Estate Investment Trust)
 RHB Trustees Berhad
 TINGKAT 11, TOWER ONE,
 RHB CENTRE, JALAN TUN RAZAK,
 60450 KUALA LUMPUR,
 WILAYAH PERSEKUTUAN KUALA LUMPUR.
 Tel: +603 9280 8799 Fax: +603 9280 8796**

T.T ARKITEK :
**KOOI KEAT ARCHITECT
 no.19, Laman Bukit Dumar, 11600 penang, malaysia.
 tel:04-659 9987 fax:04-656 8478 e-mail:kooikeat@kooikeatarchitect.com.my**

**Ar. Ooi Kooi Keat
 ARKITEK
 No. Pendaftaran LAM : A/O 61**

MAIN CONTRACTOR :
**AME CONSTRUCTION SDN BHD
 NO 18 JALAN ANGKASA MAS 6,
 KAWASAN PERINDUSTRIAN TEBRAU 2,
 81100 JOHOR BAHRU, JOHOR.
 TEL: 07- 355 5111
 FAX: 07- 3541648**

PERUNDING M & E :
**HAN YANG CONSULTANCY SDN BHD
 MECHANICAL & ELECTRICAL CONSULTING ENGINEERS
 Tingkat 1, No. 19, Lorong Desa Pauh 1,
 Taman Desa Pauh, 13700 Perai,
 Pulau Pinang.
 Tel: 04-3979100 Fax: 04-3979101
 E-mail: hanyang.sdn.bhd@gmail.com**

FIRE CONTRACTOR :
**NATION FIRE ENGINEERING SDN BHD
 (45343-D)
 20, JALAN USJ 7/3A, UEP SUBANG JAYA,
 47610 SUBANG JAYA, SELANGOR DARUL EHSAN.
 TEL: 03-5621 0805/06 FAX: 03-5621 0815
 E-MAIL: nationfire@yahoo.com**

FIRE PROTECTION SYSTEM
 TAJUK LUKISAN:
 - SITE PLAN, KEY PLAN & LOCATION PLAN
 - HYDRANT SYSTEM

SCALE : 1:500
 DATE : JANUARY 2019
 DRAWING BY : FRANCIESE KANG
 CHECK BY : STEVEN
 DRAWING NO : 3445/NF/AAC/2018-FF00

AS-BUILT DRAWING